


H.C. --- FIRE HOSE CABINET  
D.F. --- DRINK FOUNDATION  
LAV. --- LAVATORY SINK

H.C. --- FIRE HOSE CABINET  
D.F. --- DRINK FOUNDATION  
LAV. --- LAVATORY SINK


NORTH END  
GROUND FLOOR

SOUTH END  
GROUND FLOOR

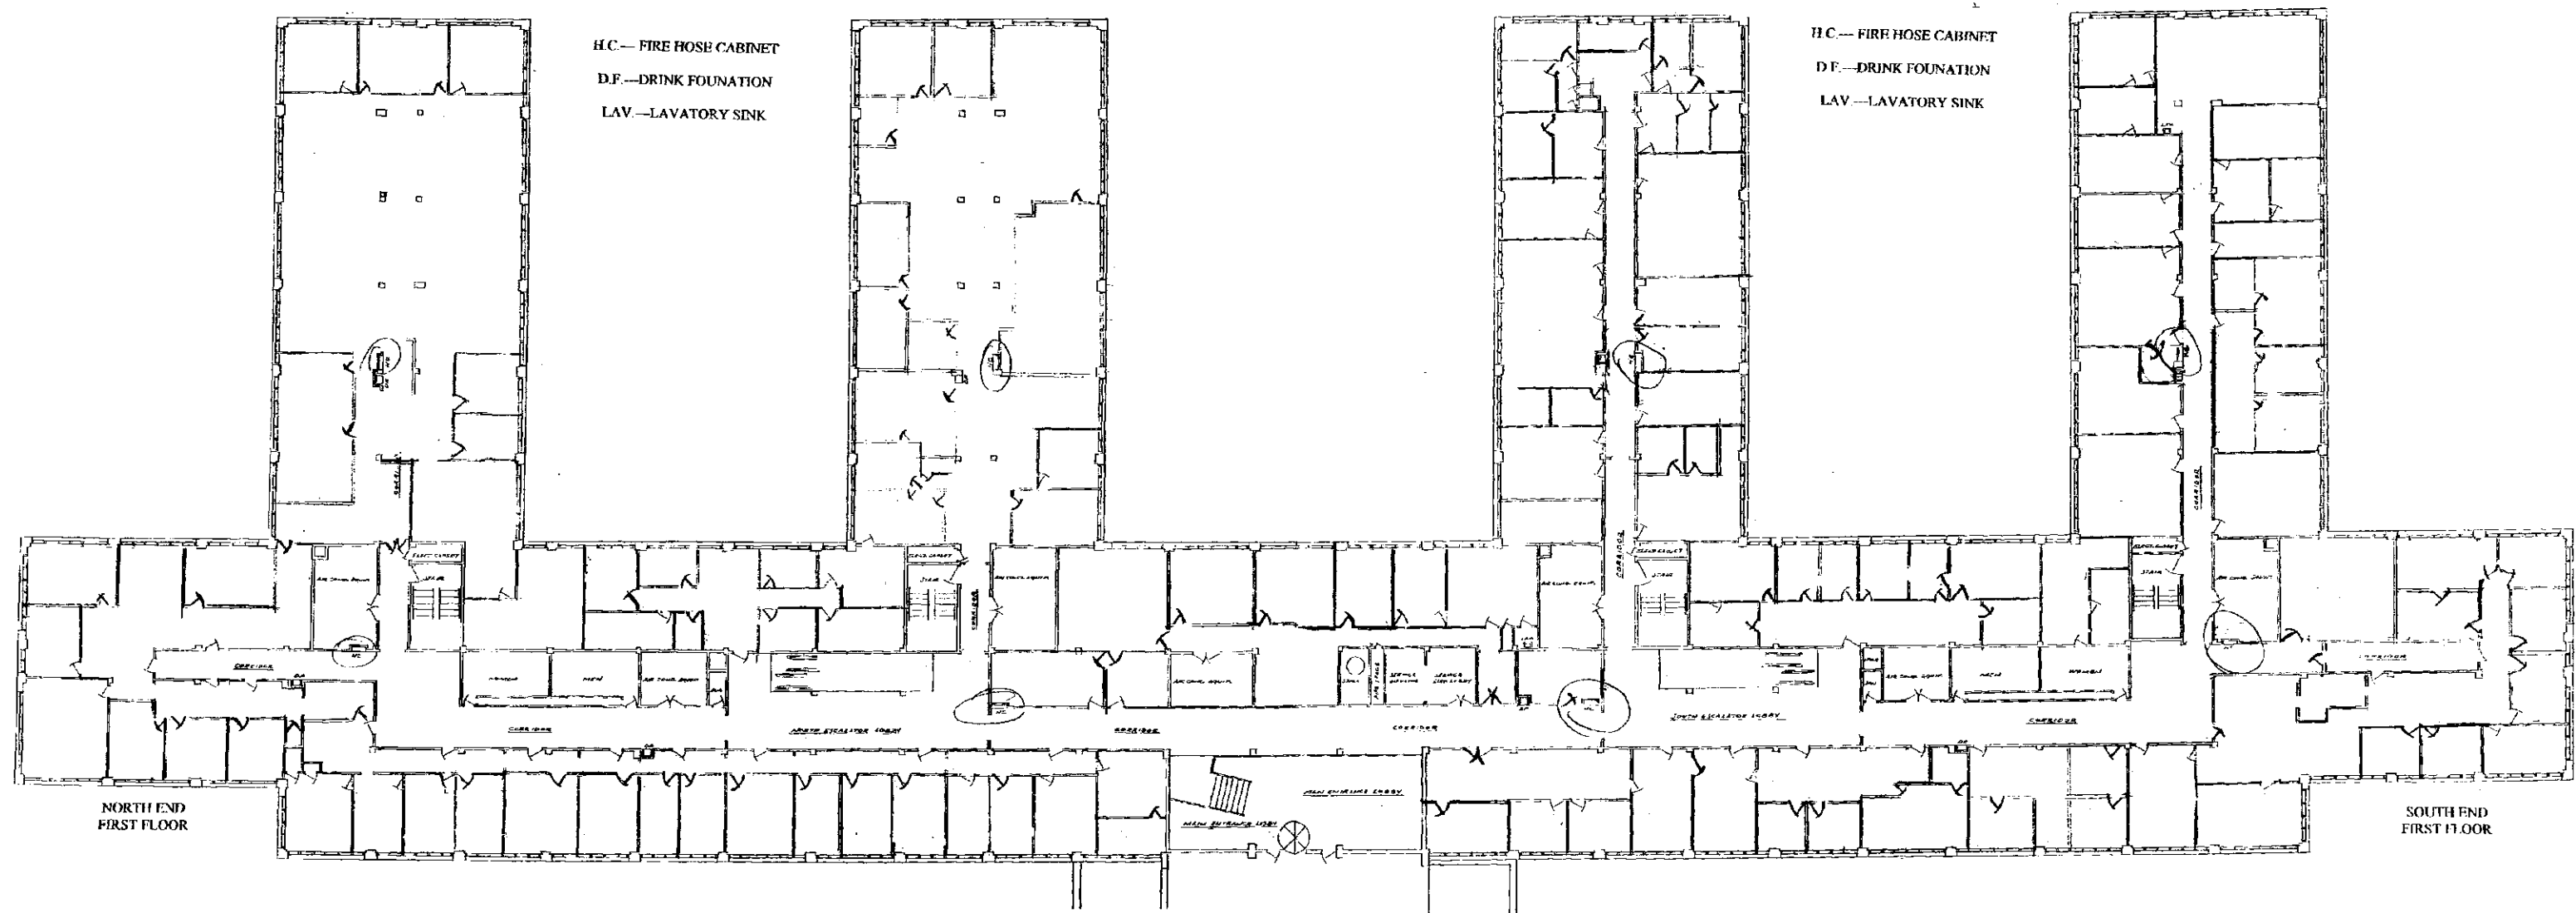


FIRST FLOOR

P A R K I N G A R E A

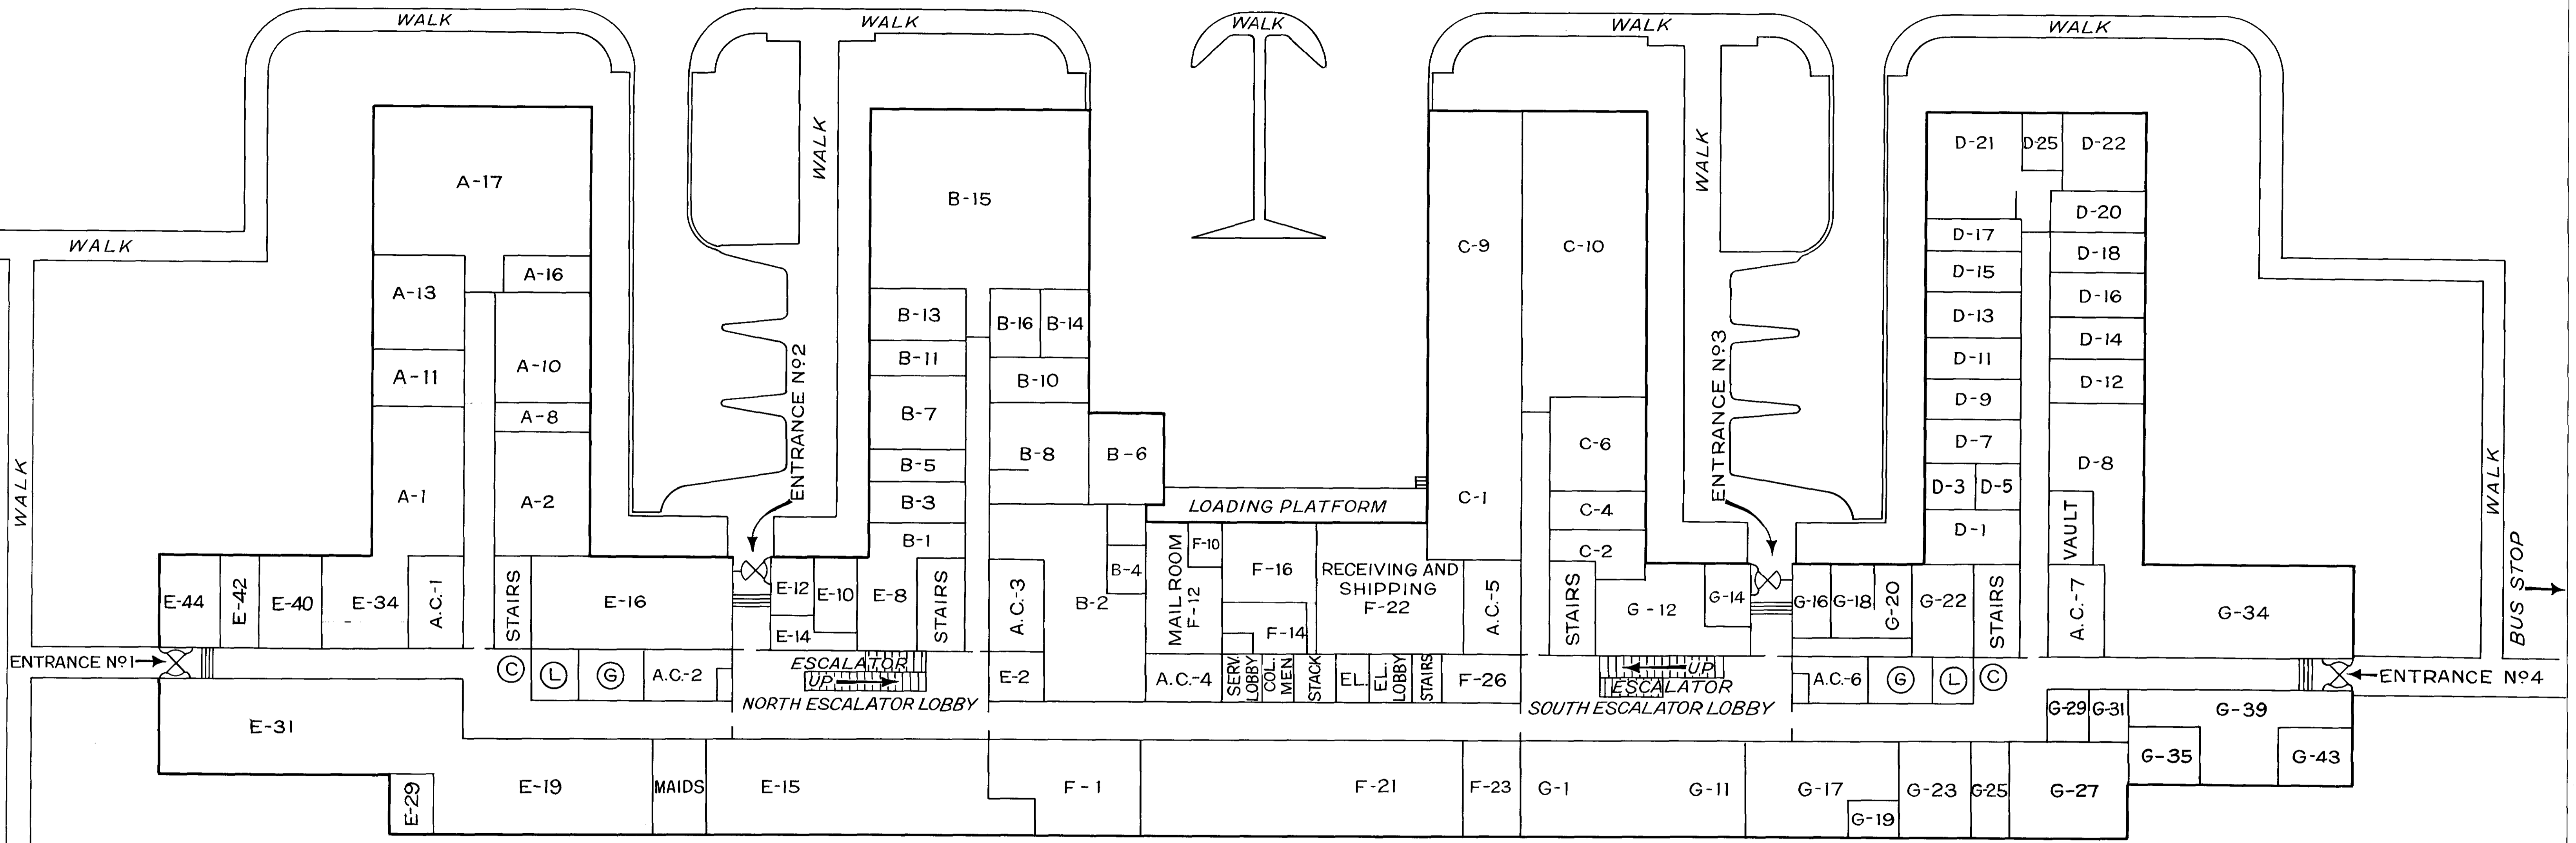


GROUND FLOOR

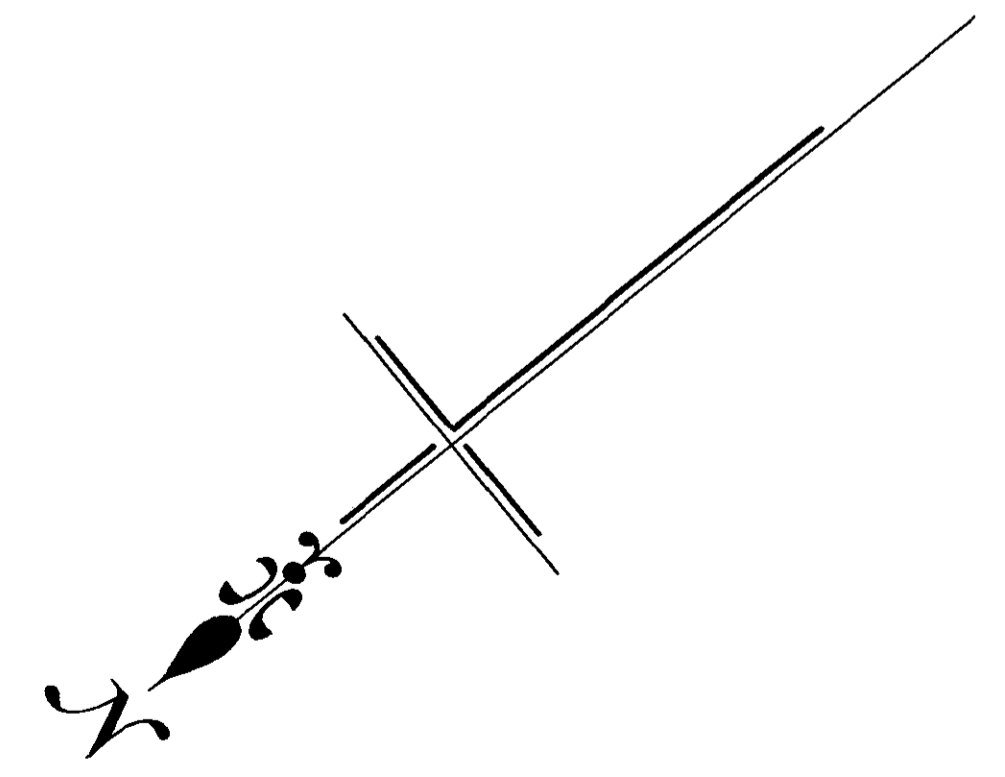


• Key •

- ⊙ CANTEEN SERVICE AREA
- ⊙ GENTLEMEN
- ⊙ LADIES
- A.C. AIRCONDITIONING UNIT
- EL. FREIGHT ELEVATOR

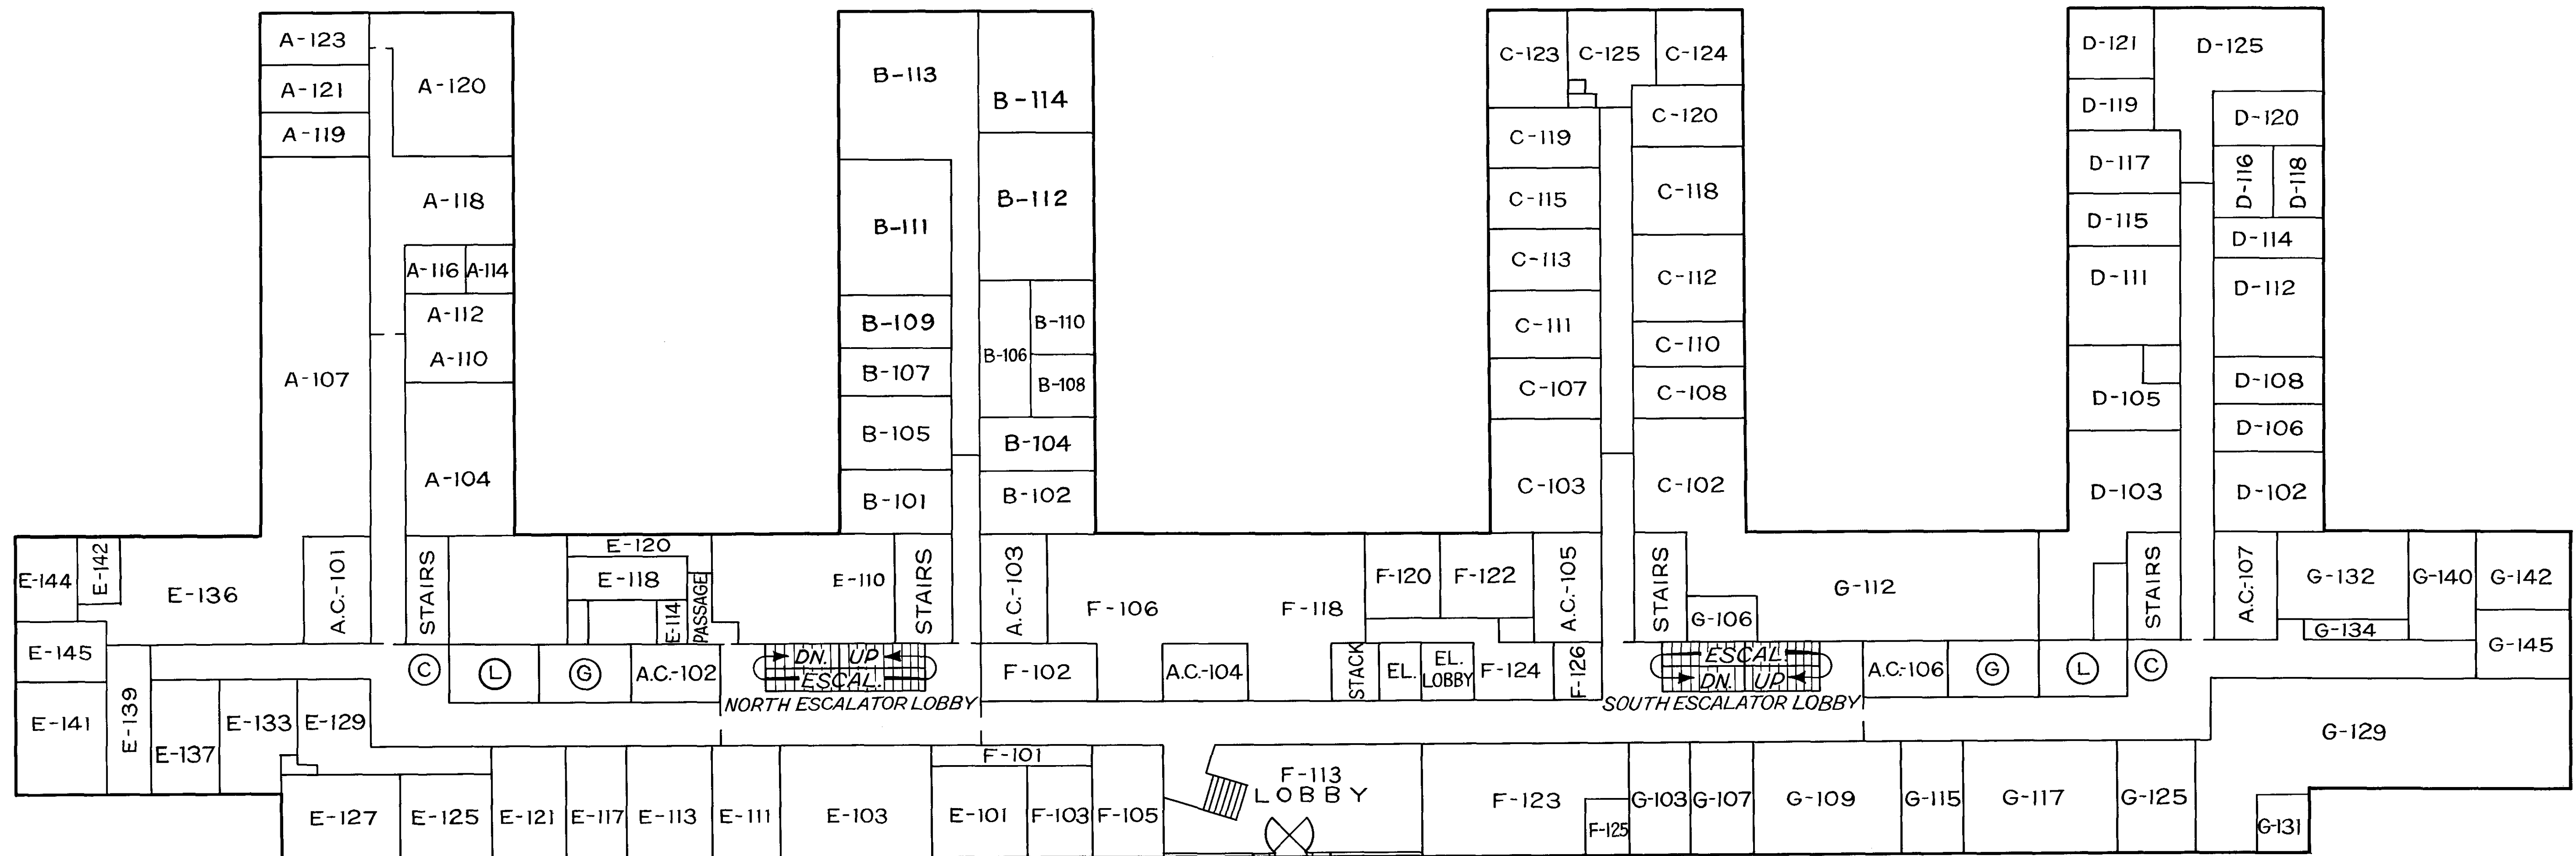


# FIRST FLOOR

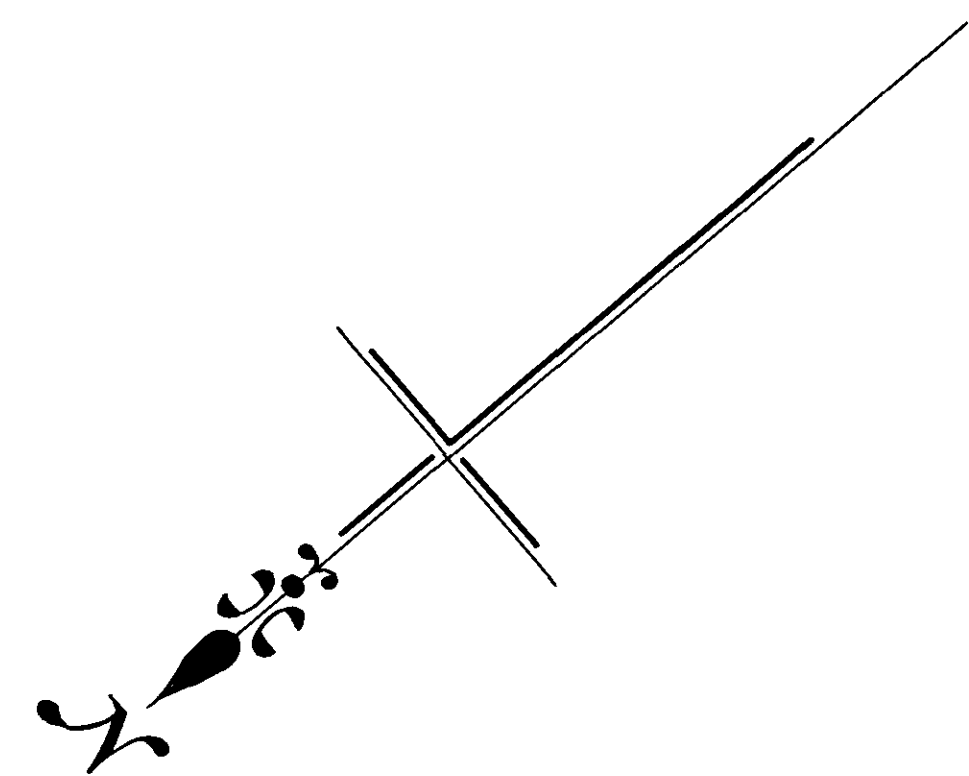


**Key**

- ⊙ CANTEEN SERVICE AREA
- ⊙ GENTLEMEN
- ⊙ LADIES
- A.C. AIR CONDITIONING UNIT
- EL. FREIGHT ELEVATOR

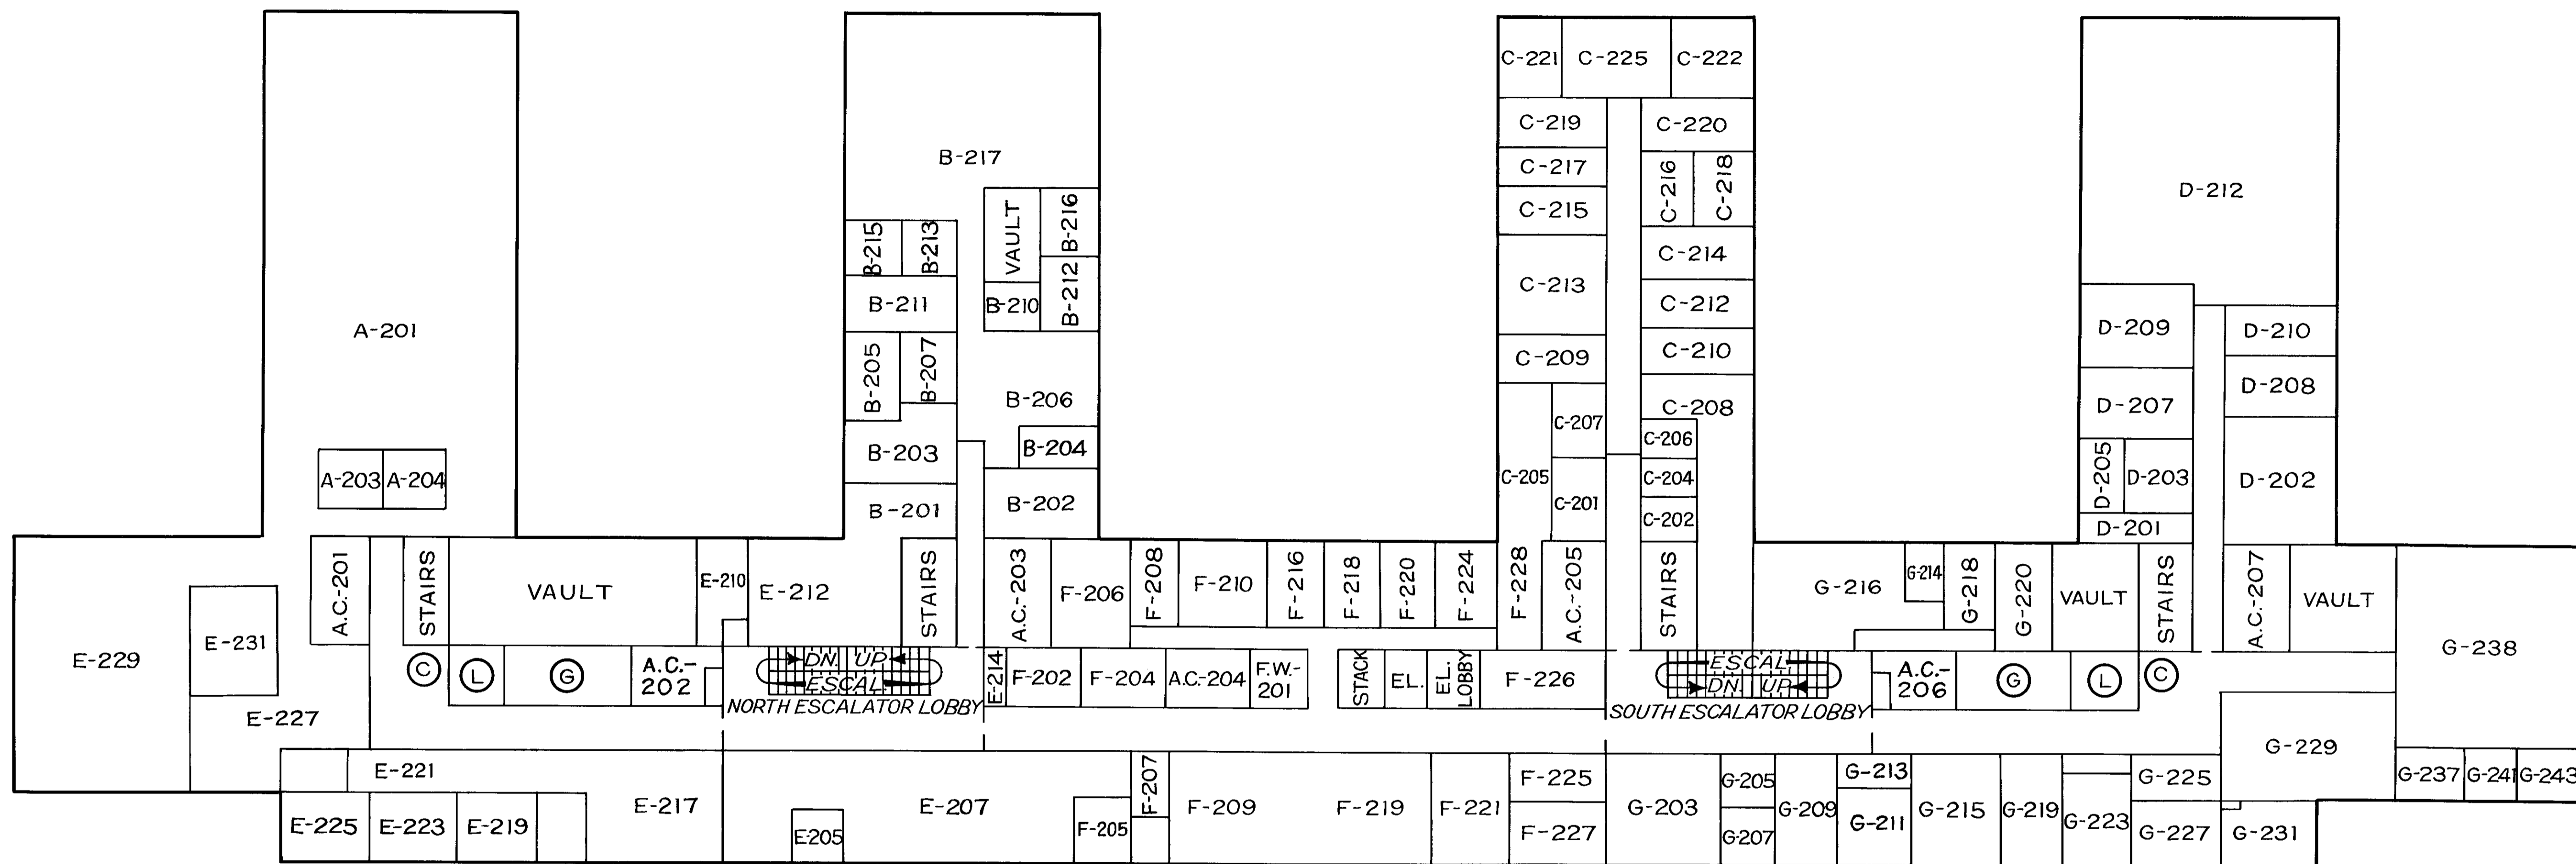


## SECOND FLOOR

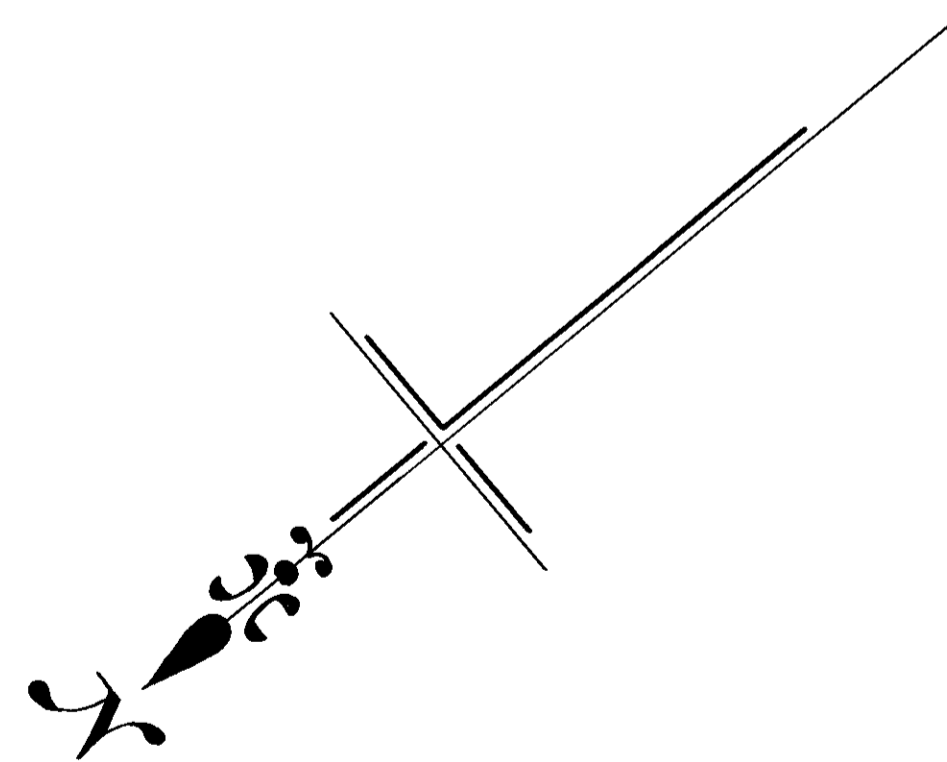

**Key**

- Ⓢ CANTEEN SERVICE AREA
- Ⓜ GENTLEMEN
- Ⓛ LADIES
  
- A.C. AIR CONDITIONING UNIT
- EL. FREIGHT ELEVATOR

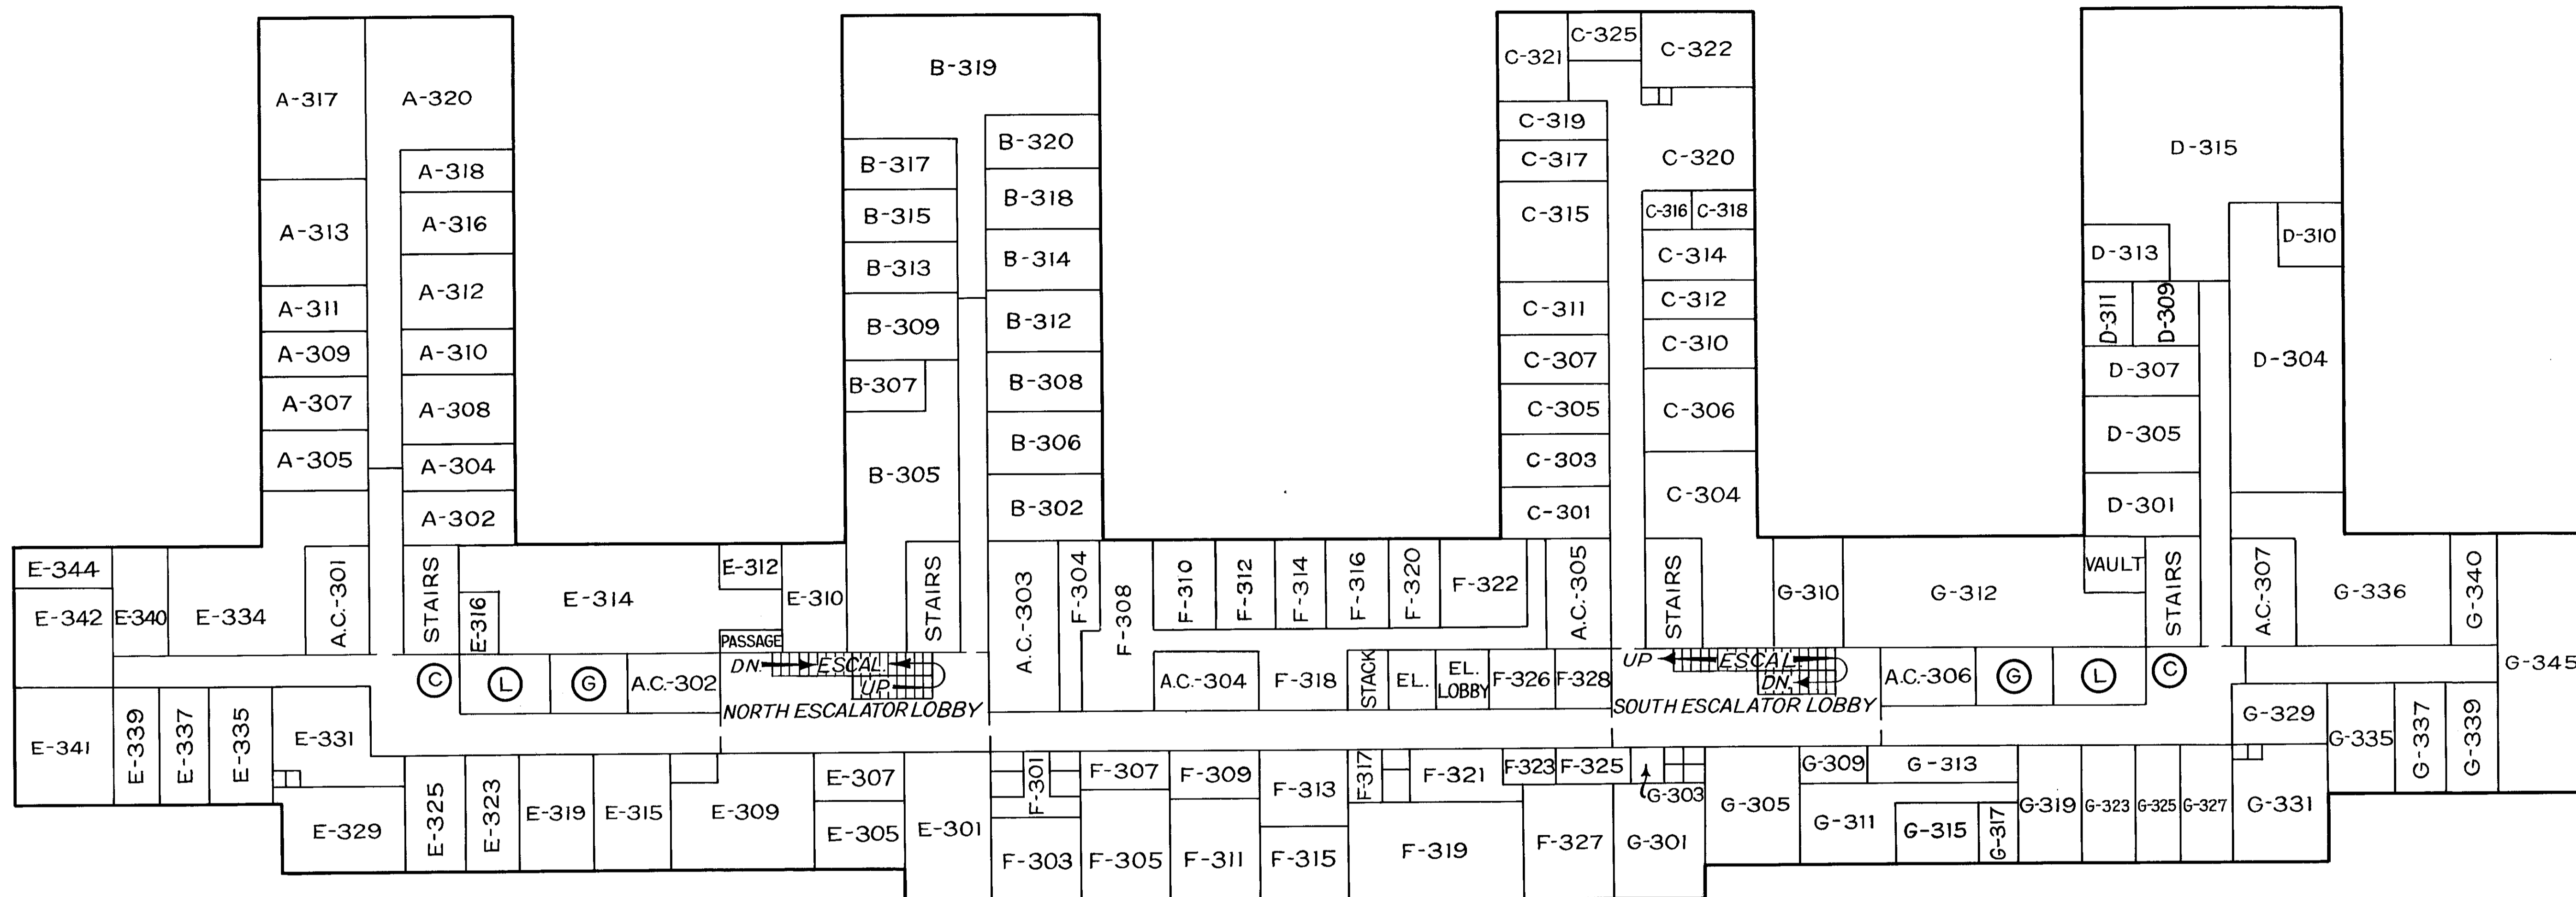


## THIRD FLOOR

**Key**











- Ⓒ CANTEEN SERVICE AREA
- Ⓔ GENTLEMEN
- Ⓕ LADIES

A.C. AIR CONDITIONING UNIT  
EL. FREIGHT ELEVATOR

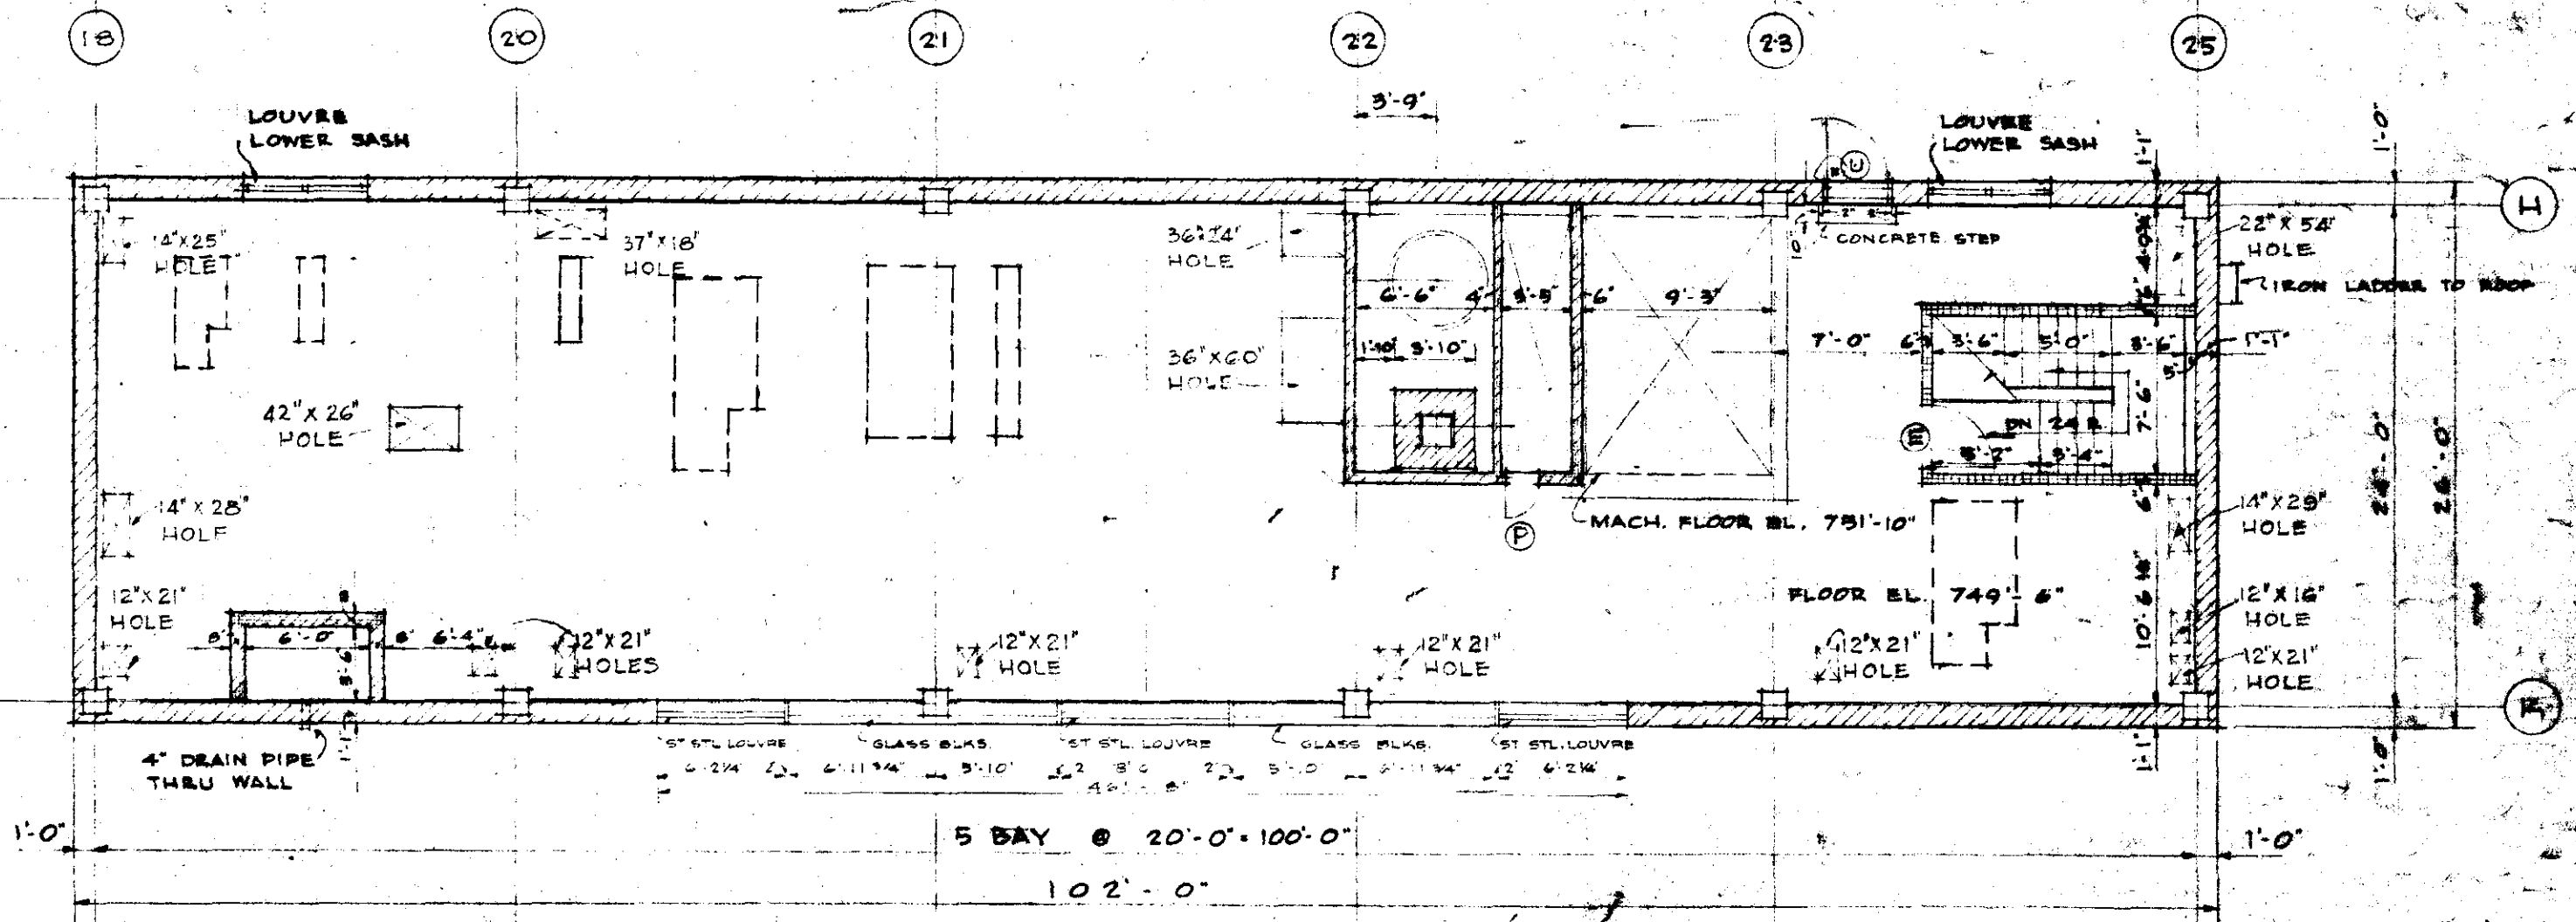

PENT HOUSE FLOOR PLAN  
SCALE 1/8" = 1'-0"

NOTE: CONCRETE EQUIPMENT FOUNDATIONS INDICATED BY HEAVY DASH LINES. INFORMATION TO BE FURNISHED BY SHOP DRAWINGS OF EQUIPMENT MANUFACTURERS.

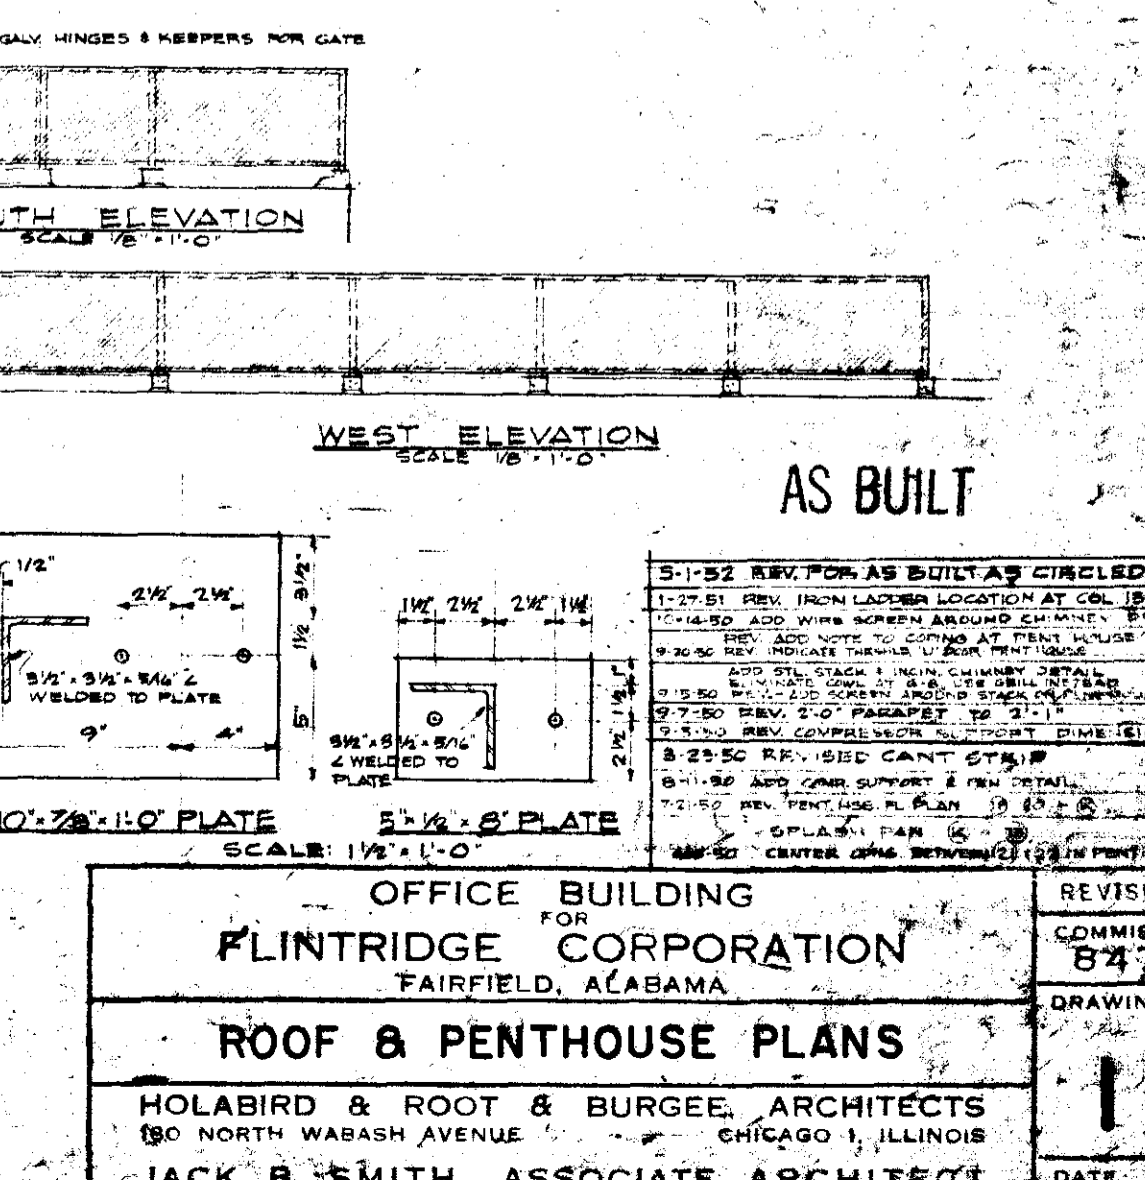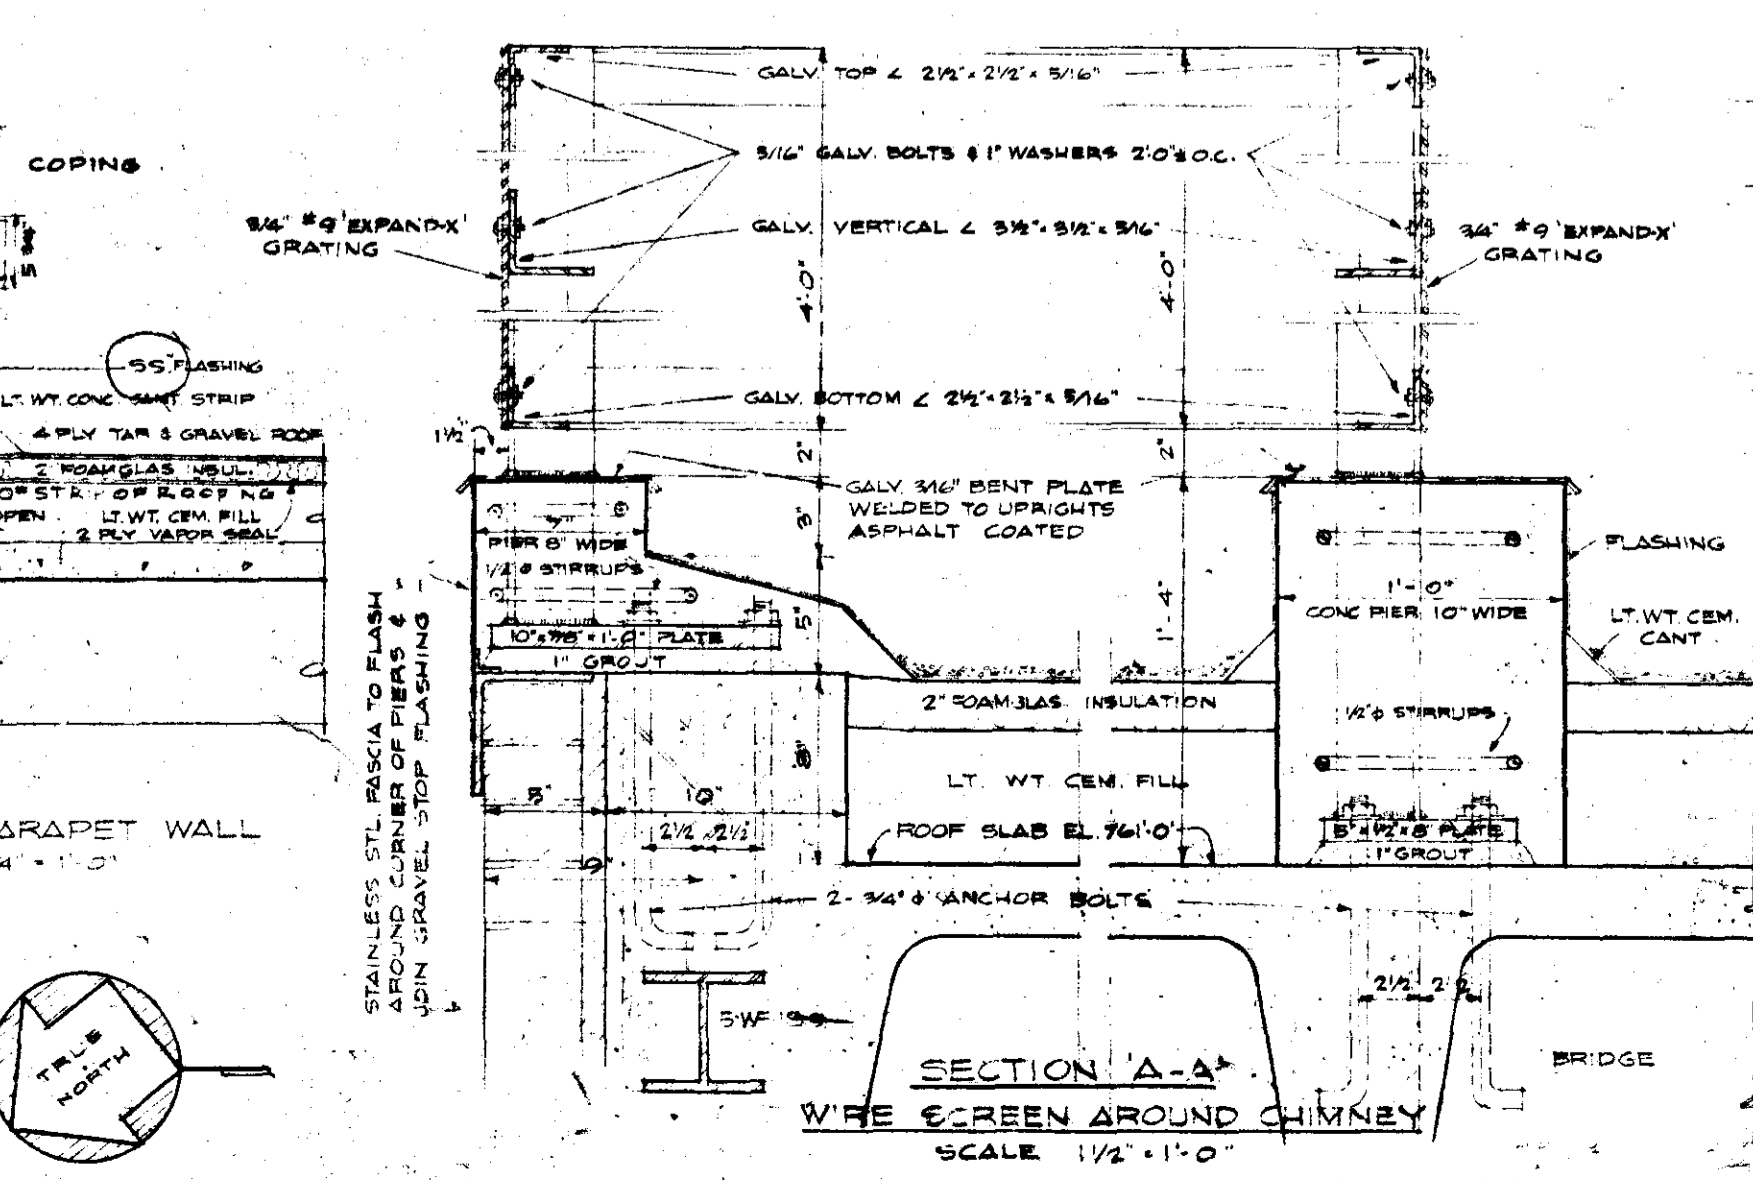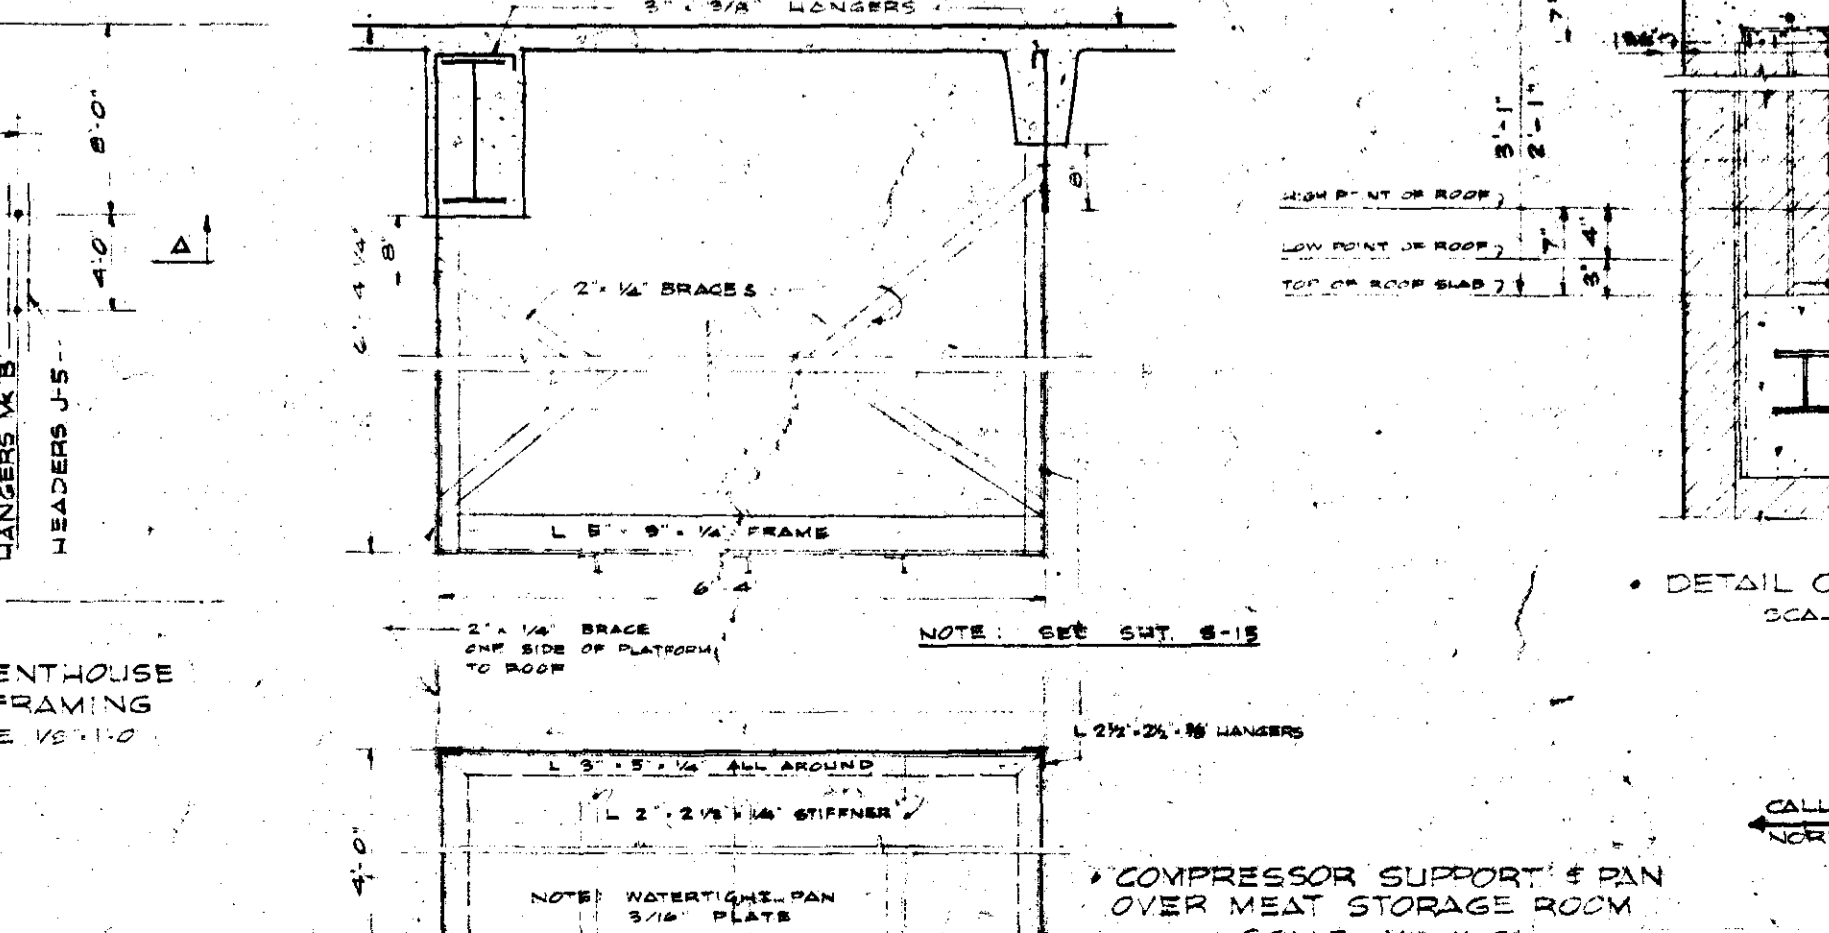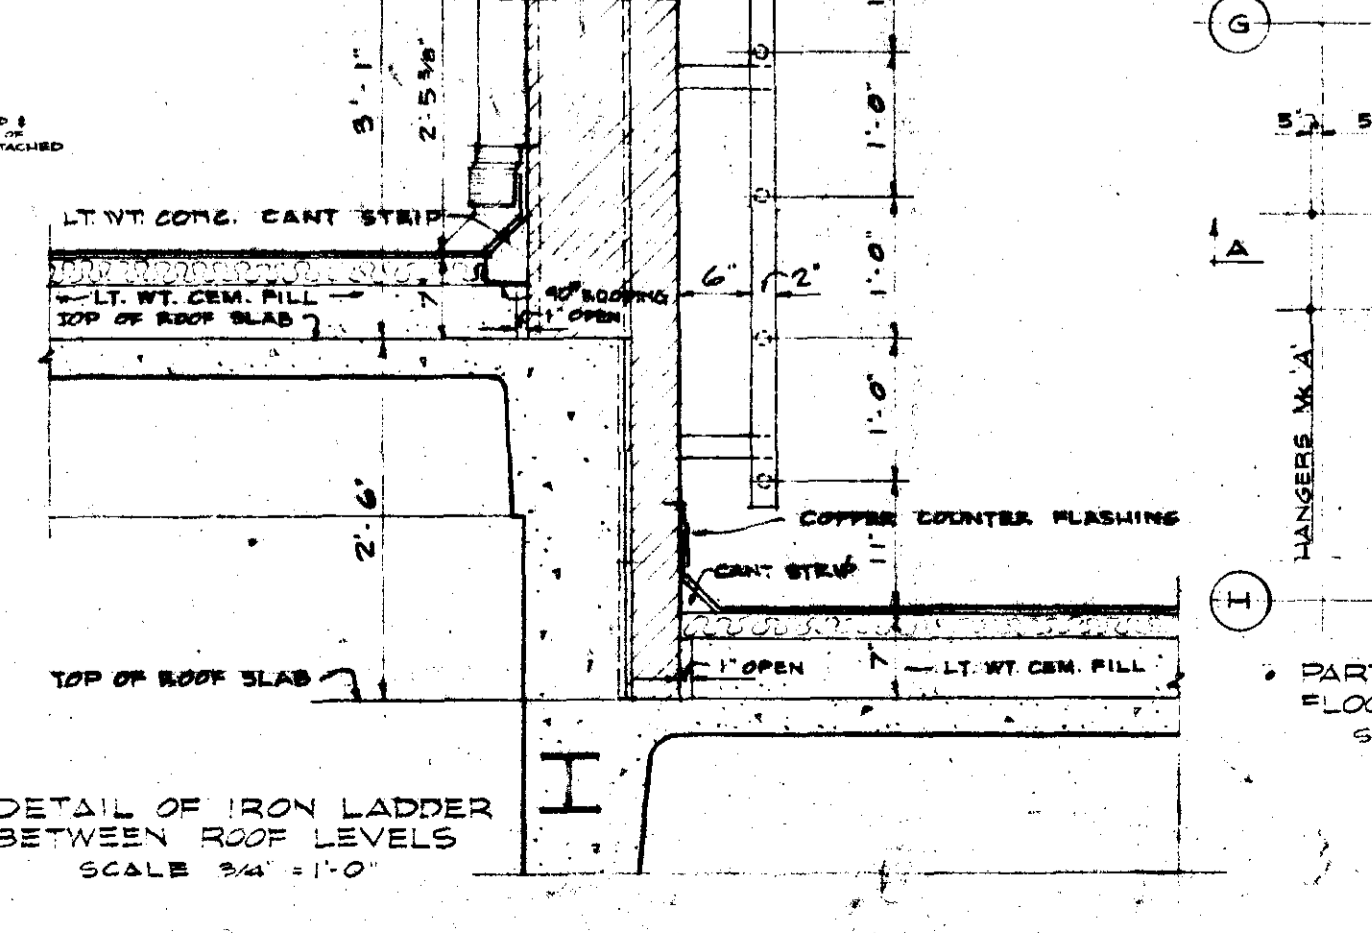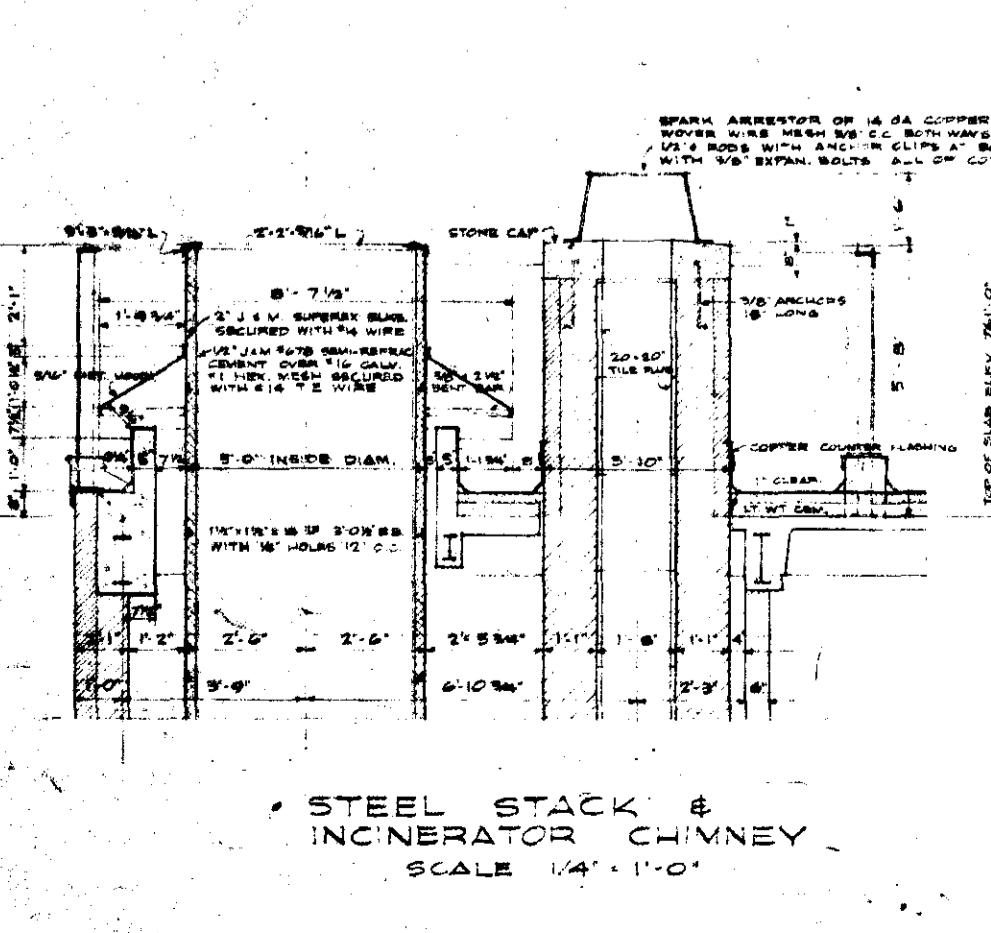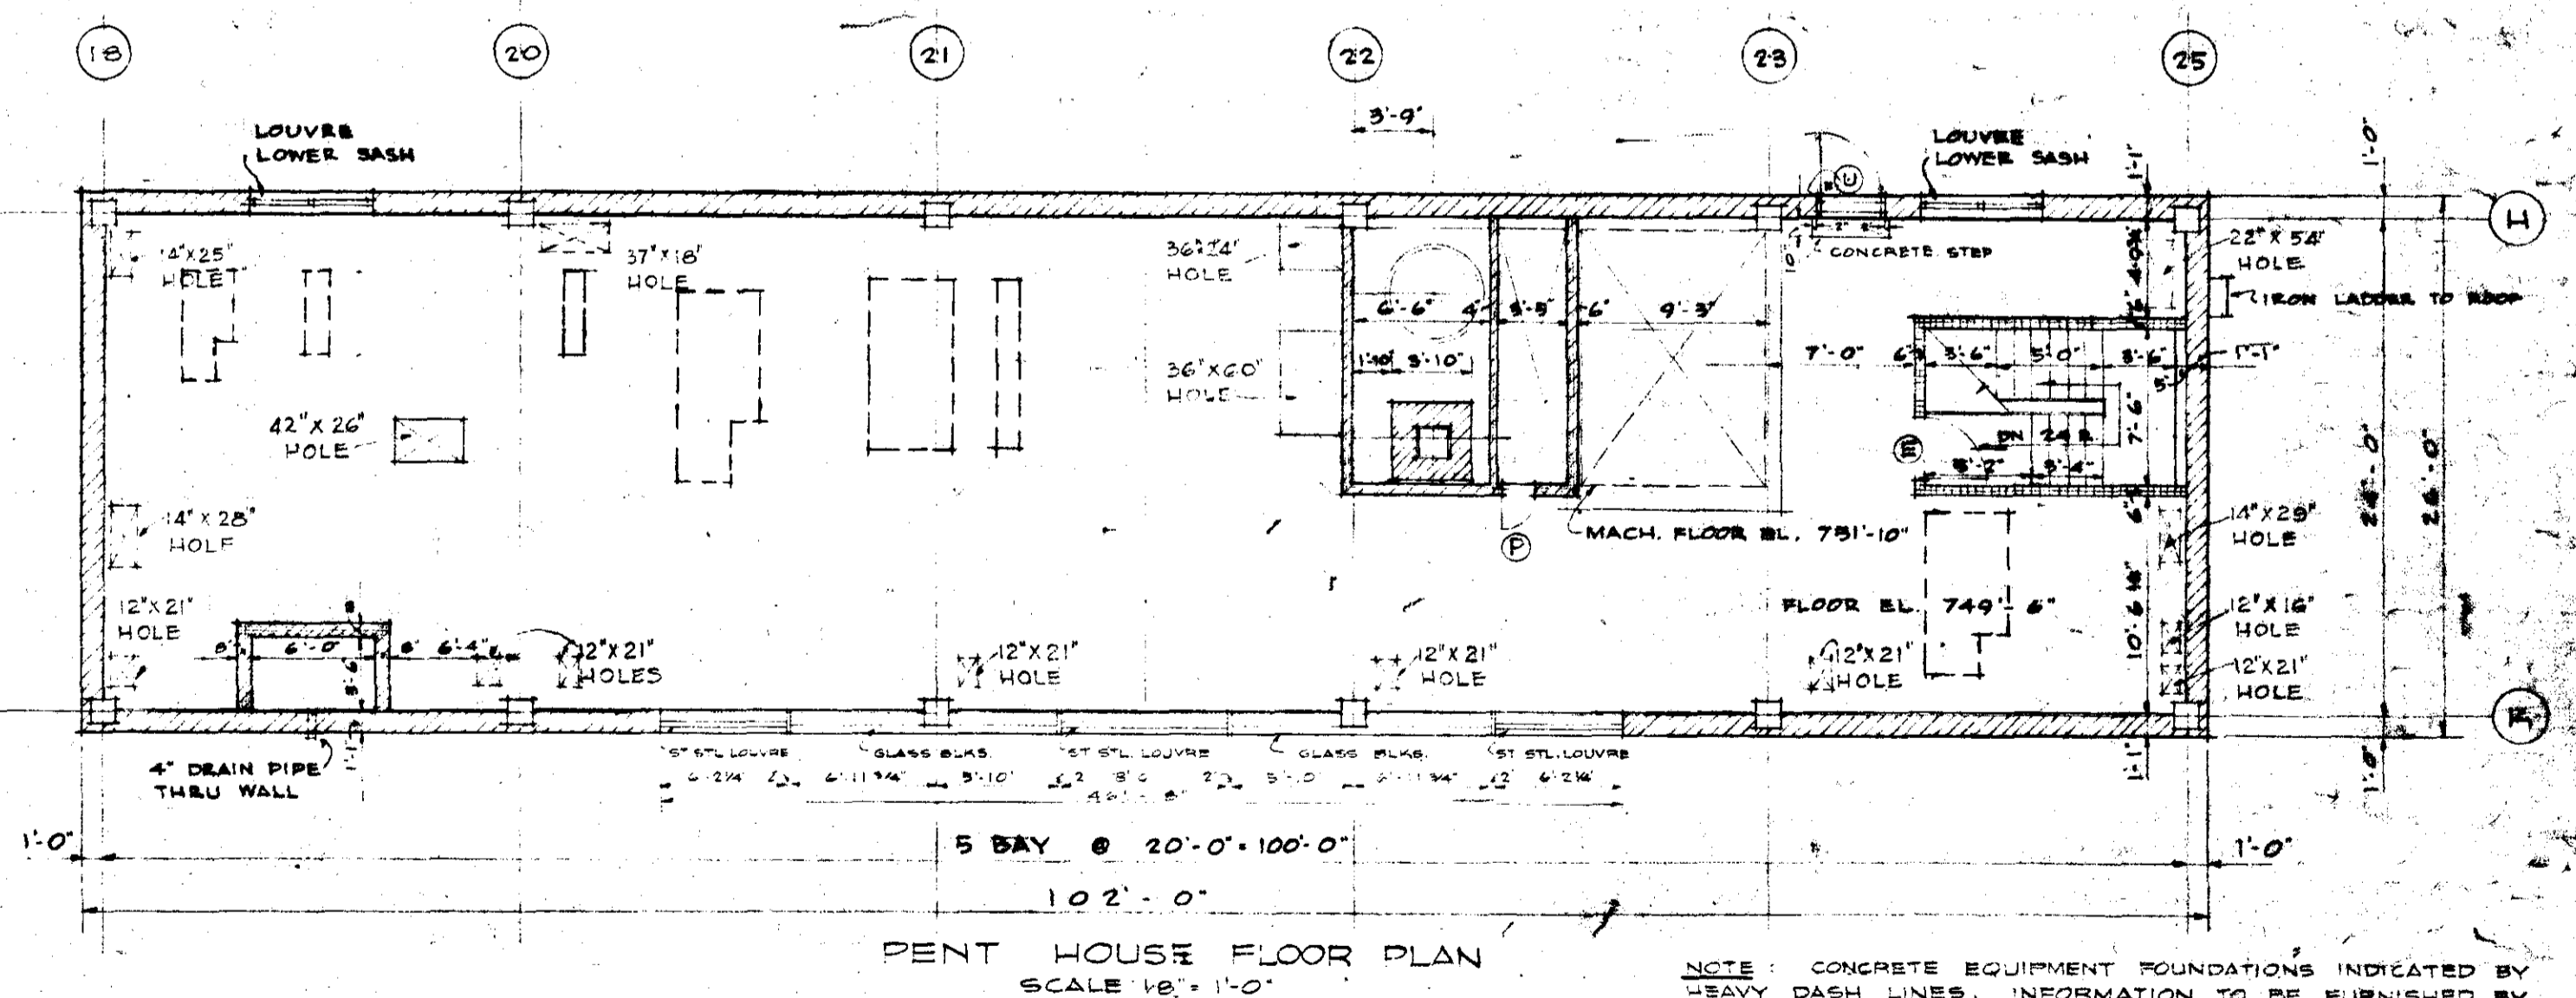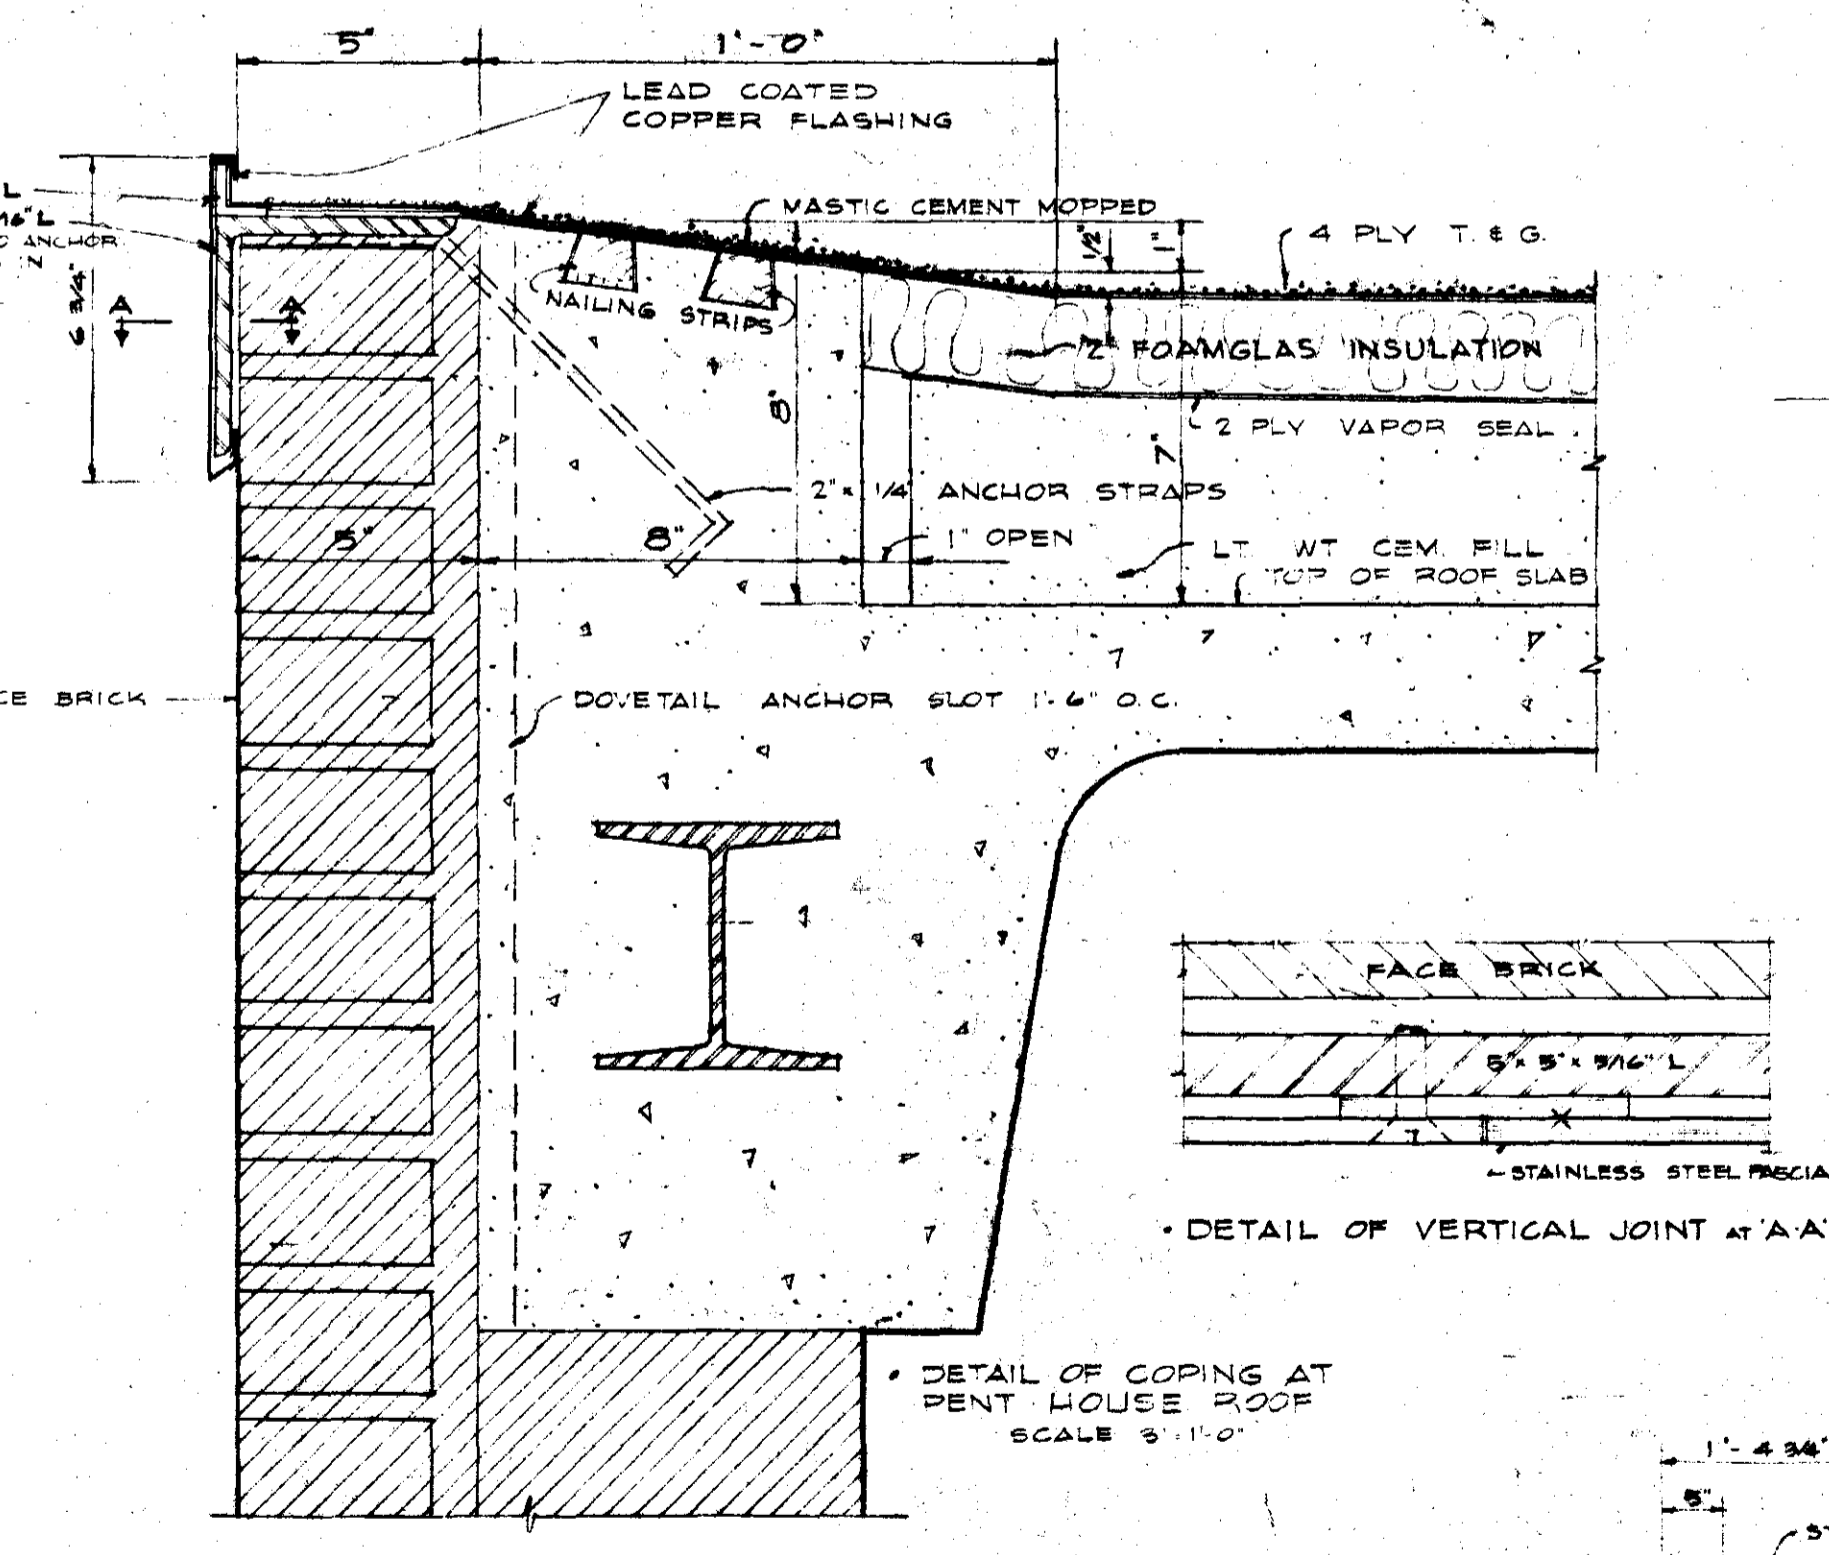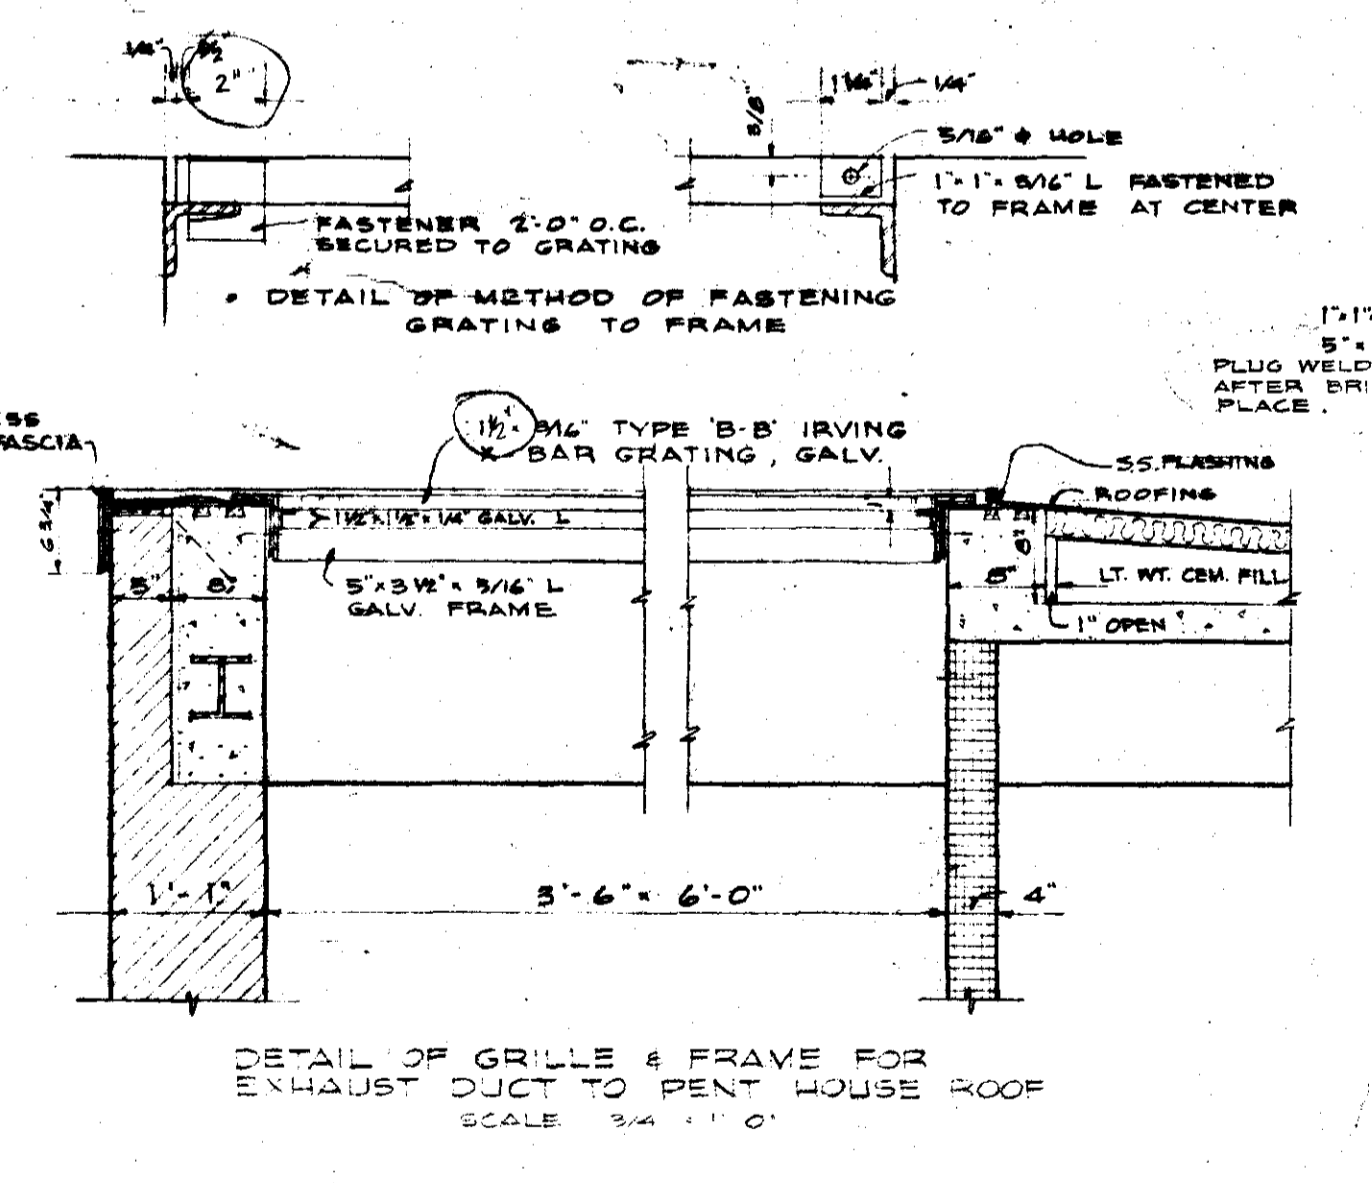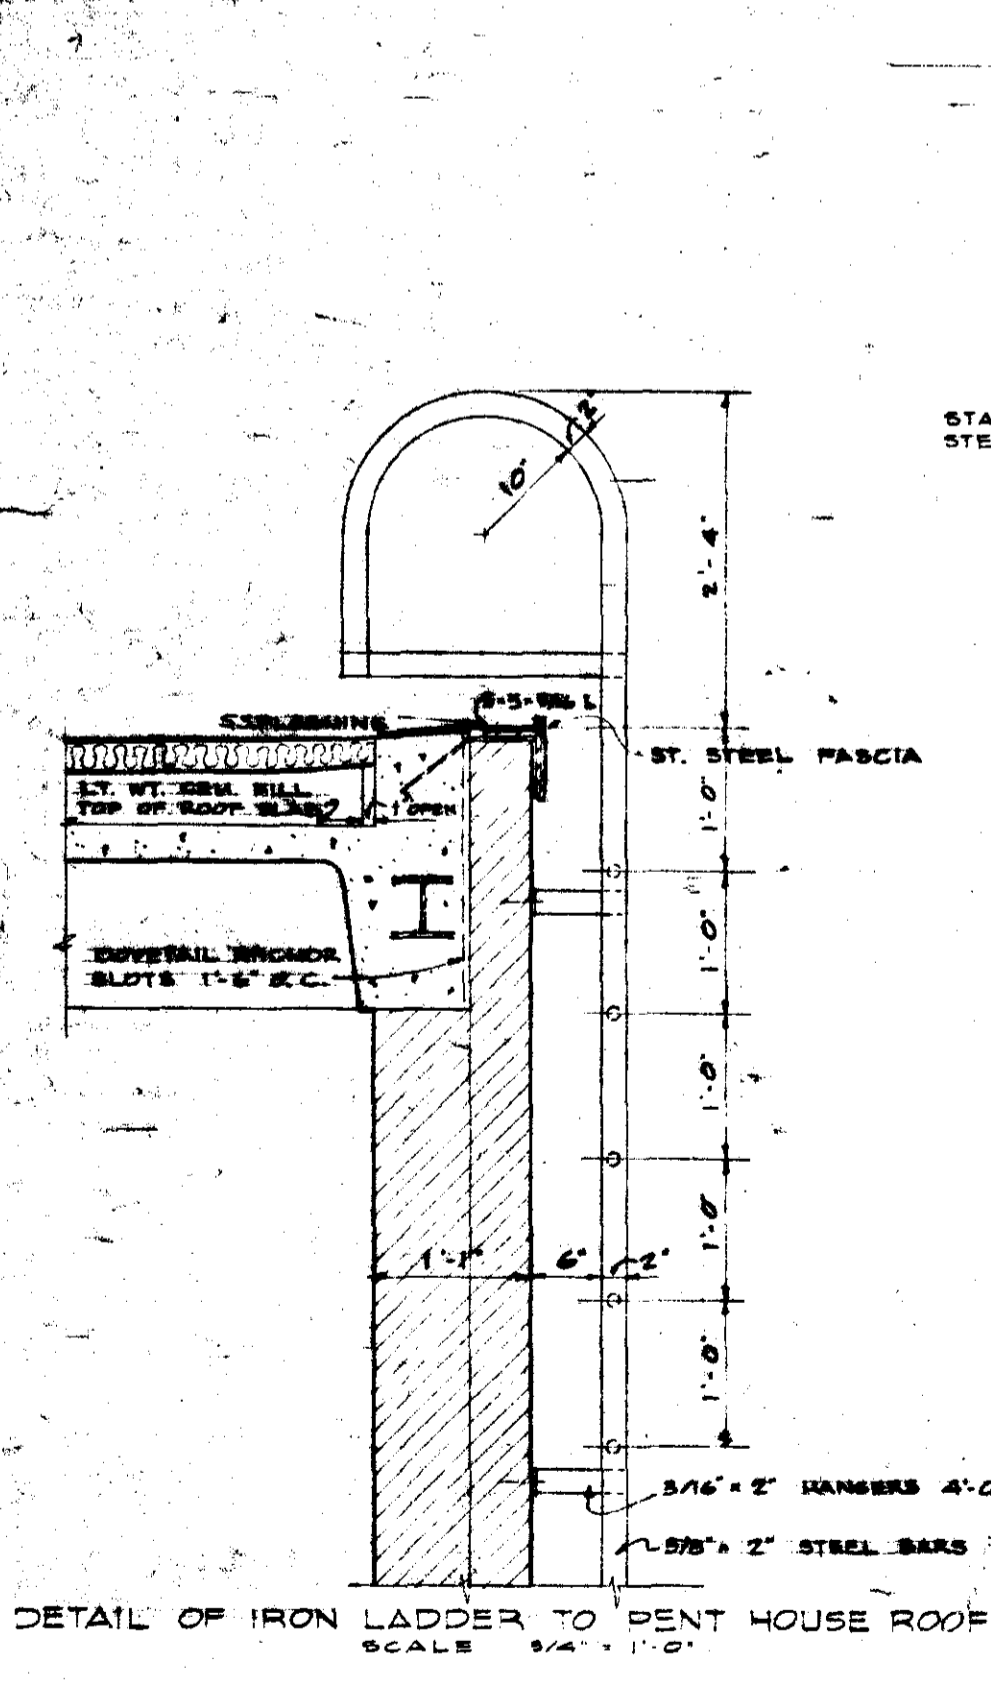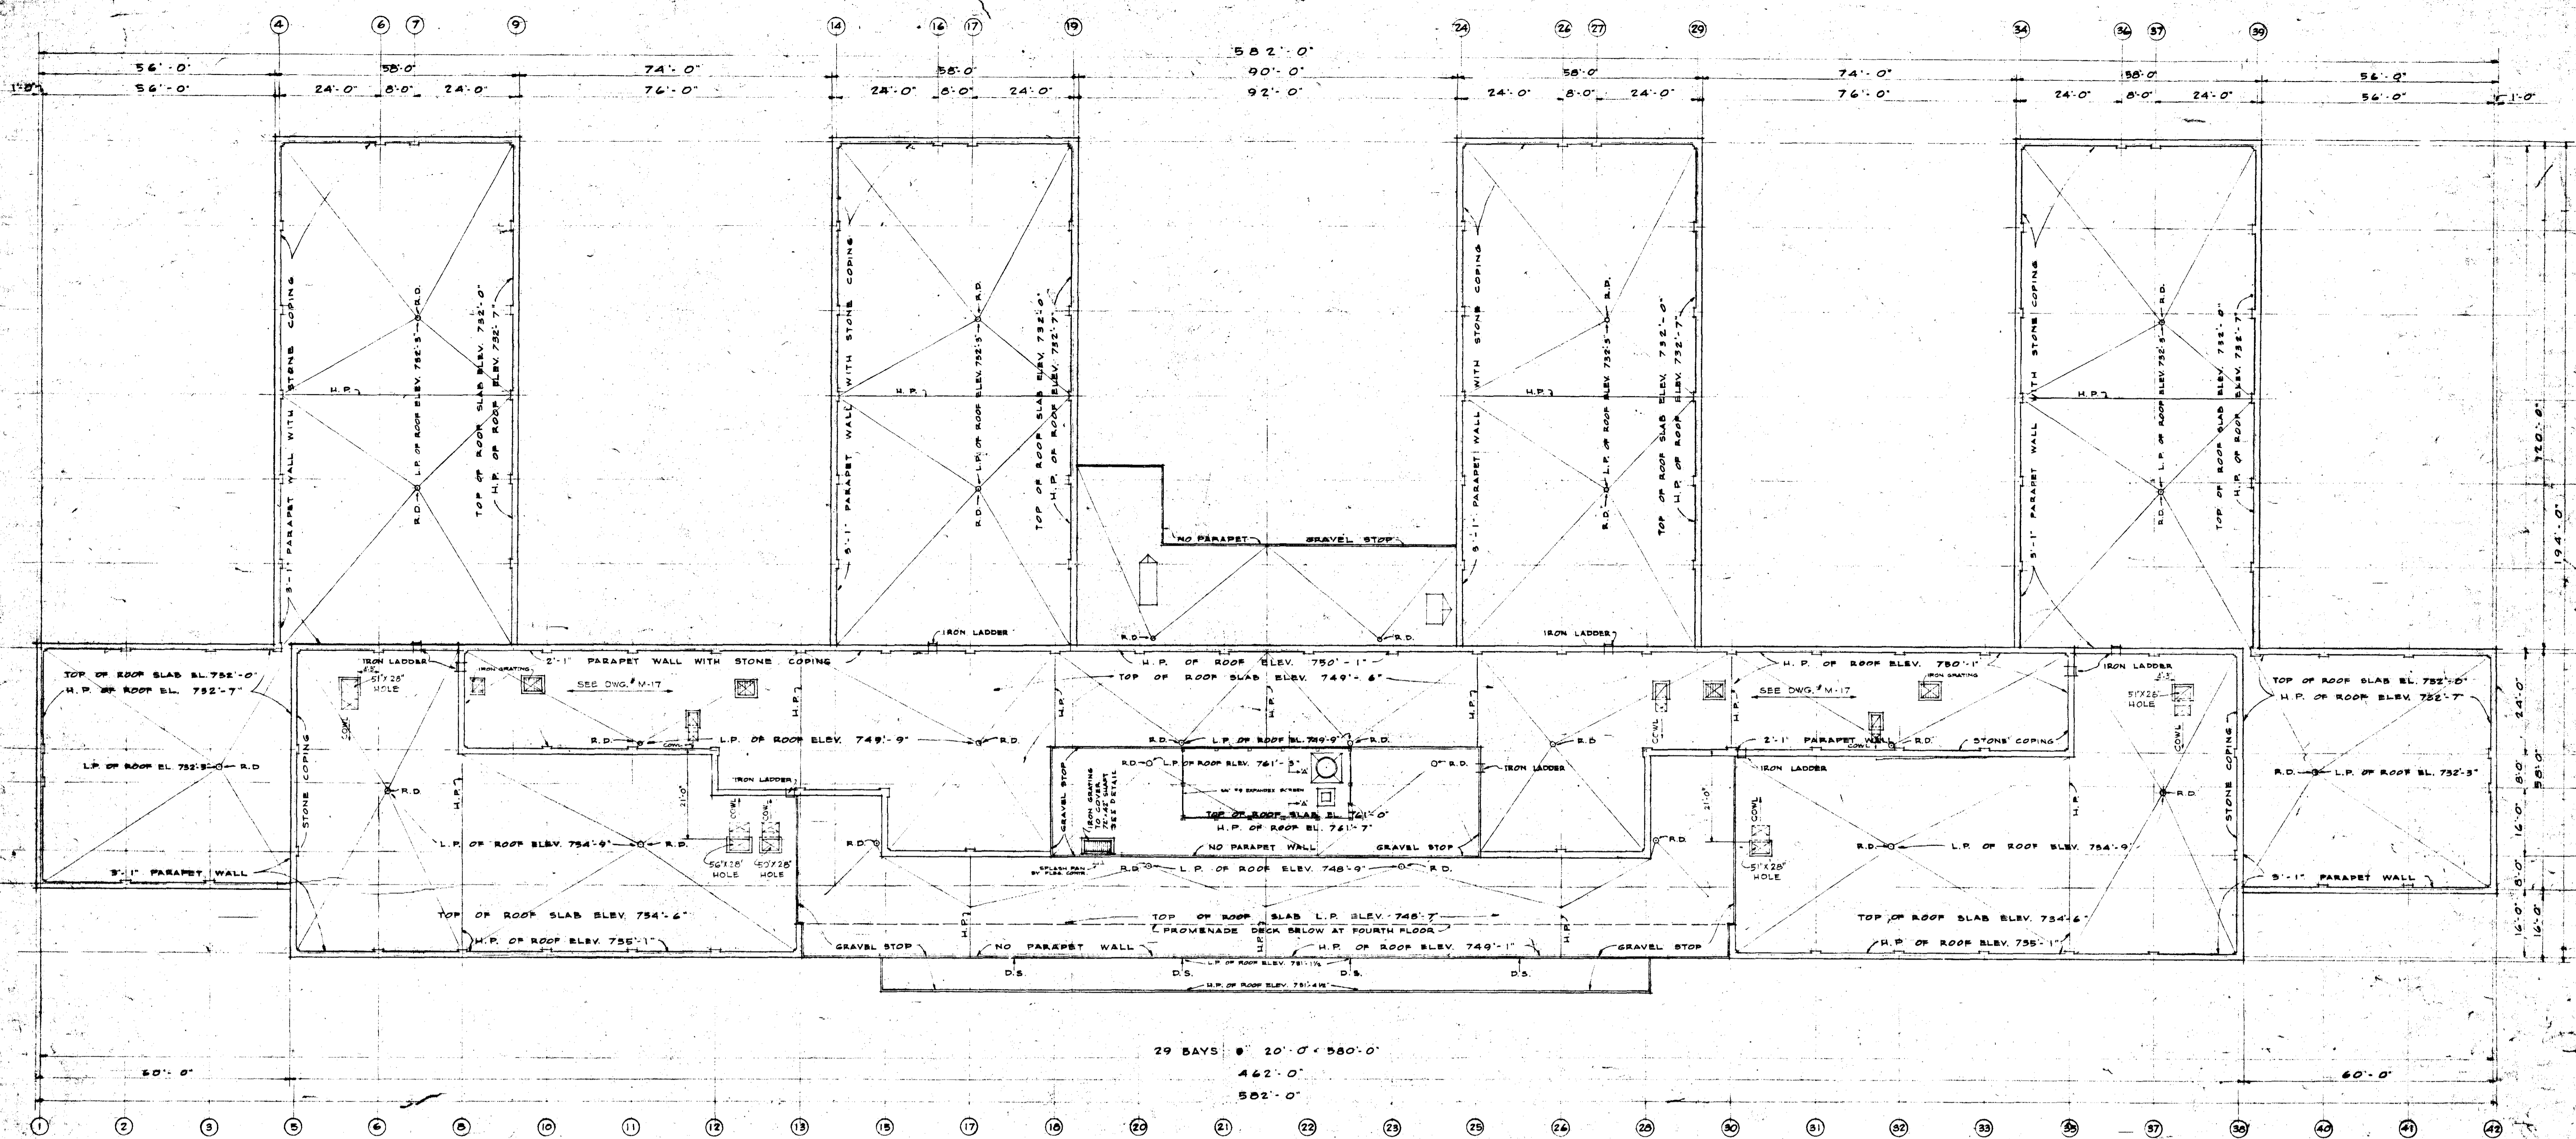

AS BUILT

OFFICE BUILDING  
FLINTRIDGE CORPORATION  
FAIRFIELD, ALABAMA

ROOF & PENTHOUSE PLANS

HOLABIRD & ROOT & BURGEE ARCHITECTS  
80 NORTH WABASH AVENUE  
CHICAGO, ILLINOIS

JACK B. SMITH, ASSOCIATE ARCHITECT  
1109 FRANK NEASEN BUILDING  
BIRMINGHAM, ALABAMA

COMMISSION 57273  
DRAWING NO. 111  
DATE 5-1-36